
 


THIS DOCUMENT IS A PARTIAL EXTRACT FROM THE COMPLETE SET OF DRAWINGS. IT IS NOT AN INSTRUMENT OF SERVICE. IT IS THE PROPERTY OF KLEINSCHMIDT AND SHOULD NOT BE REPRODUCED OR TRANSMITTED IN ANY FORM OR BY ANY MEANS, ELECTRONIC OR MECHANICAL, INCLUDING PHOTOCOPYING, RECORDING, OR BY ANY INFORMATION STORAGE AND RETRIEVAL SYSTEM, WITHOUT THE EXPRESS WRITTEN PERMISSION OF KLEINSCHMIDT ASSOCIATES.

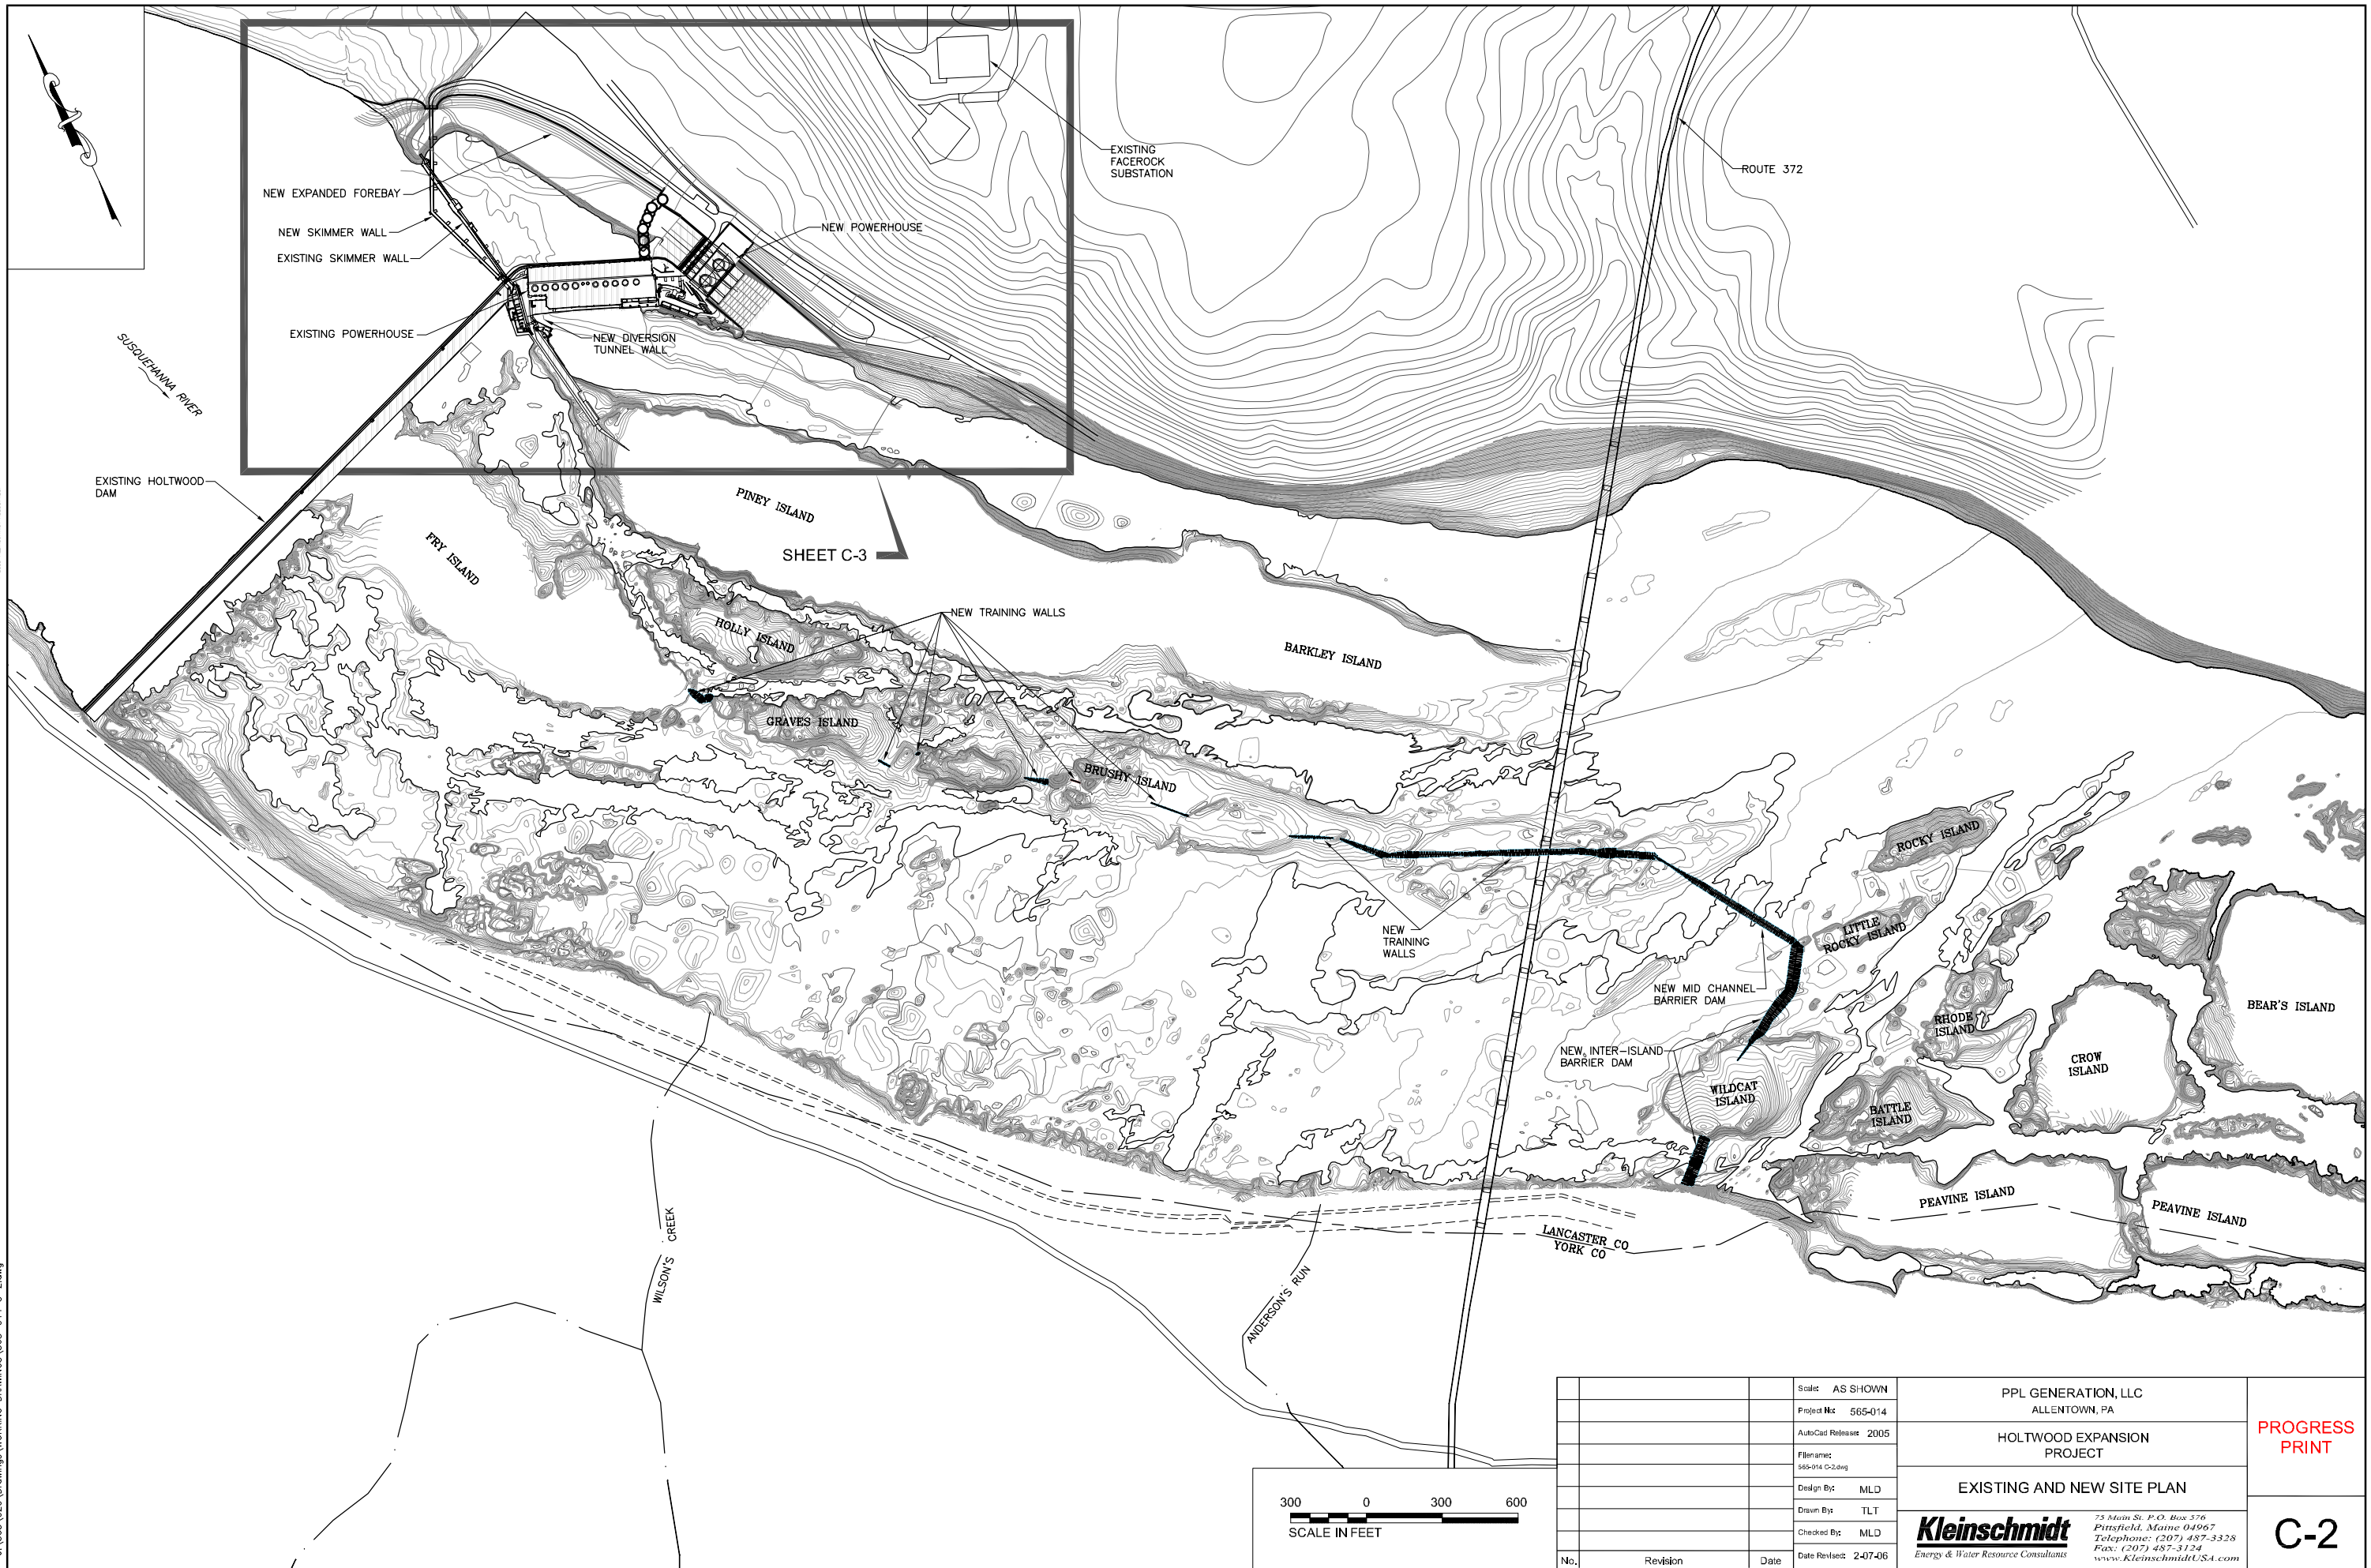

J:\565\020 Drawings\WORKING DRAWINGS\565-014 C-2.dwg



Scale:	AS SHOWN	PPL GENERATION, LLC ALLENTOWN, PA	PROGRESS PRINT
Project No:	565-014		
AutoCad Release:	2005	HOLTWOOD EXPANSION PROJECT	C-2
Filename:	565-014 C-2.dwg		
Design By:	MLD	EXISTING AND NEW SITE PLAN	Kleinschmidt Energy & Water Resource Consultants
Drawn By:	TLT		
Checked By:	MLD	75 Main St., P.O. Box 376 Pittsfield, Maine 04967 Telephone: (207) 487-3328 Fax: (207) 487-3124 www.KleinschmidtUSA.com	
Date Revised:	2-07-06		
No.	Revision	Date	